





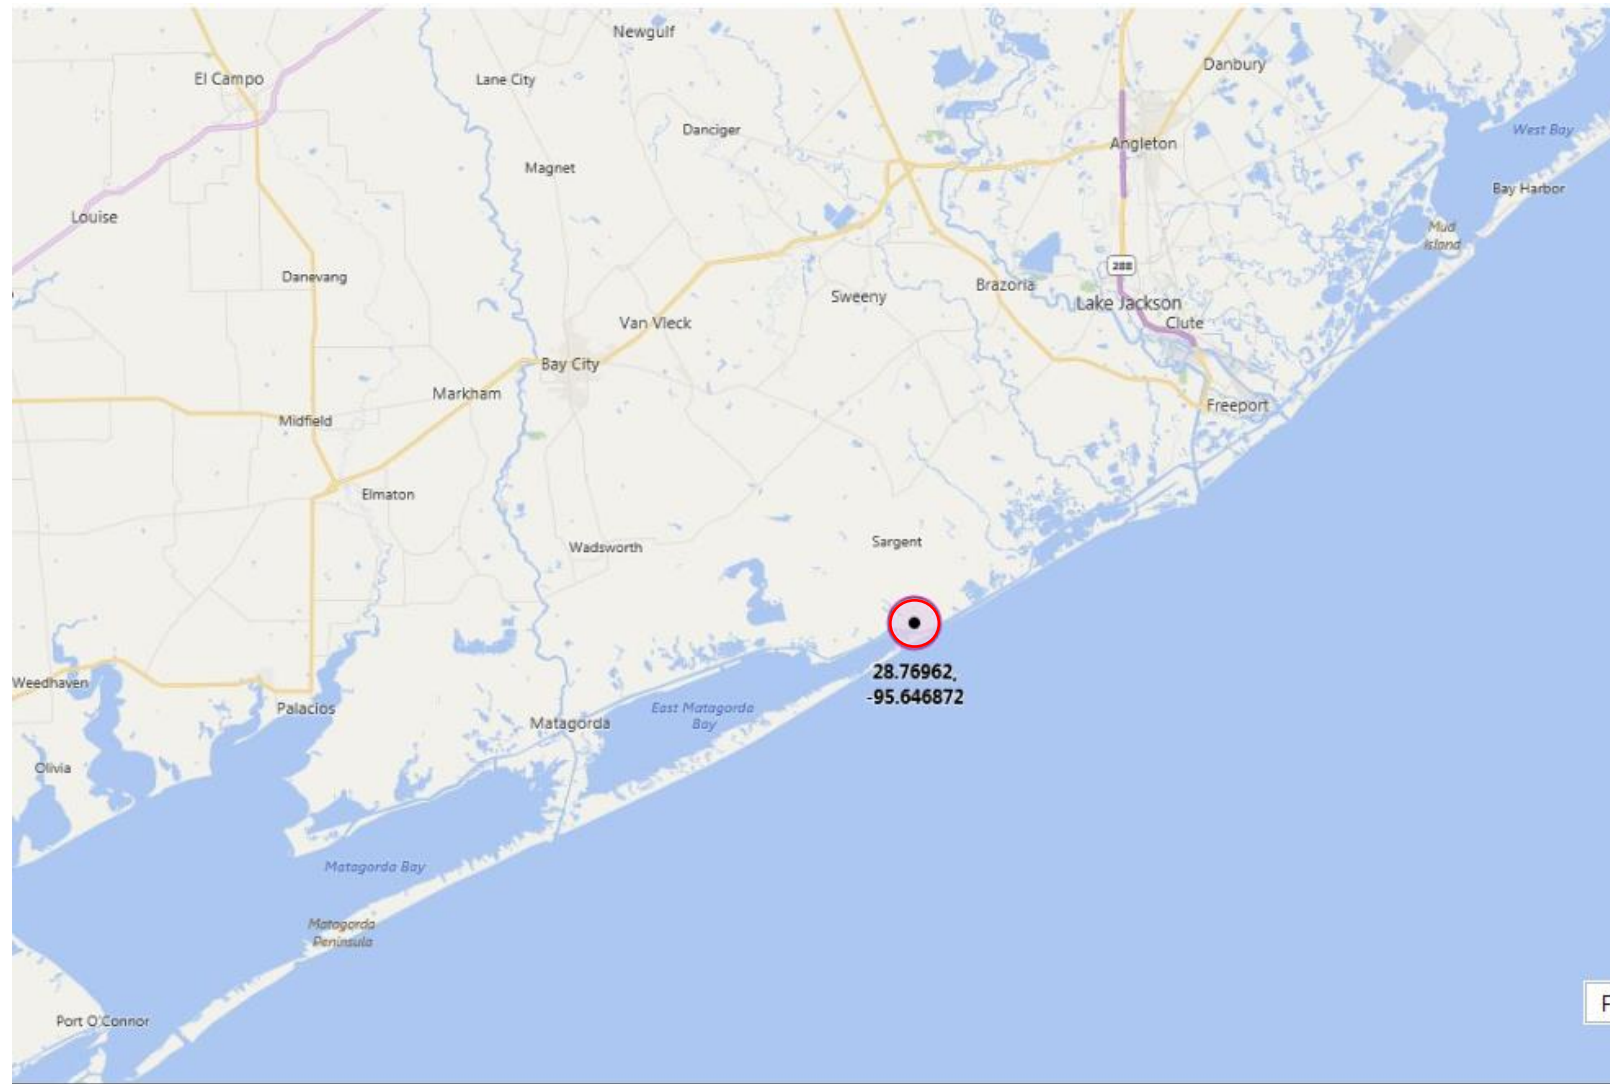


○ Approximate Project Center

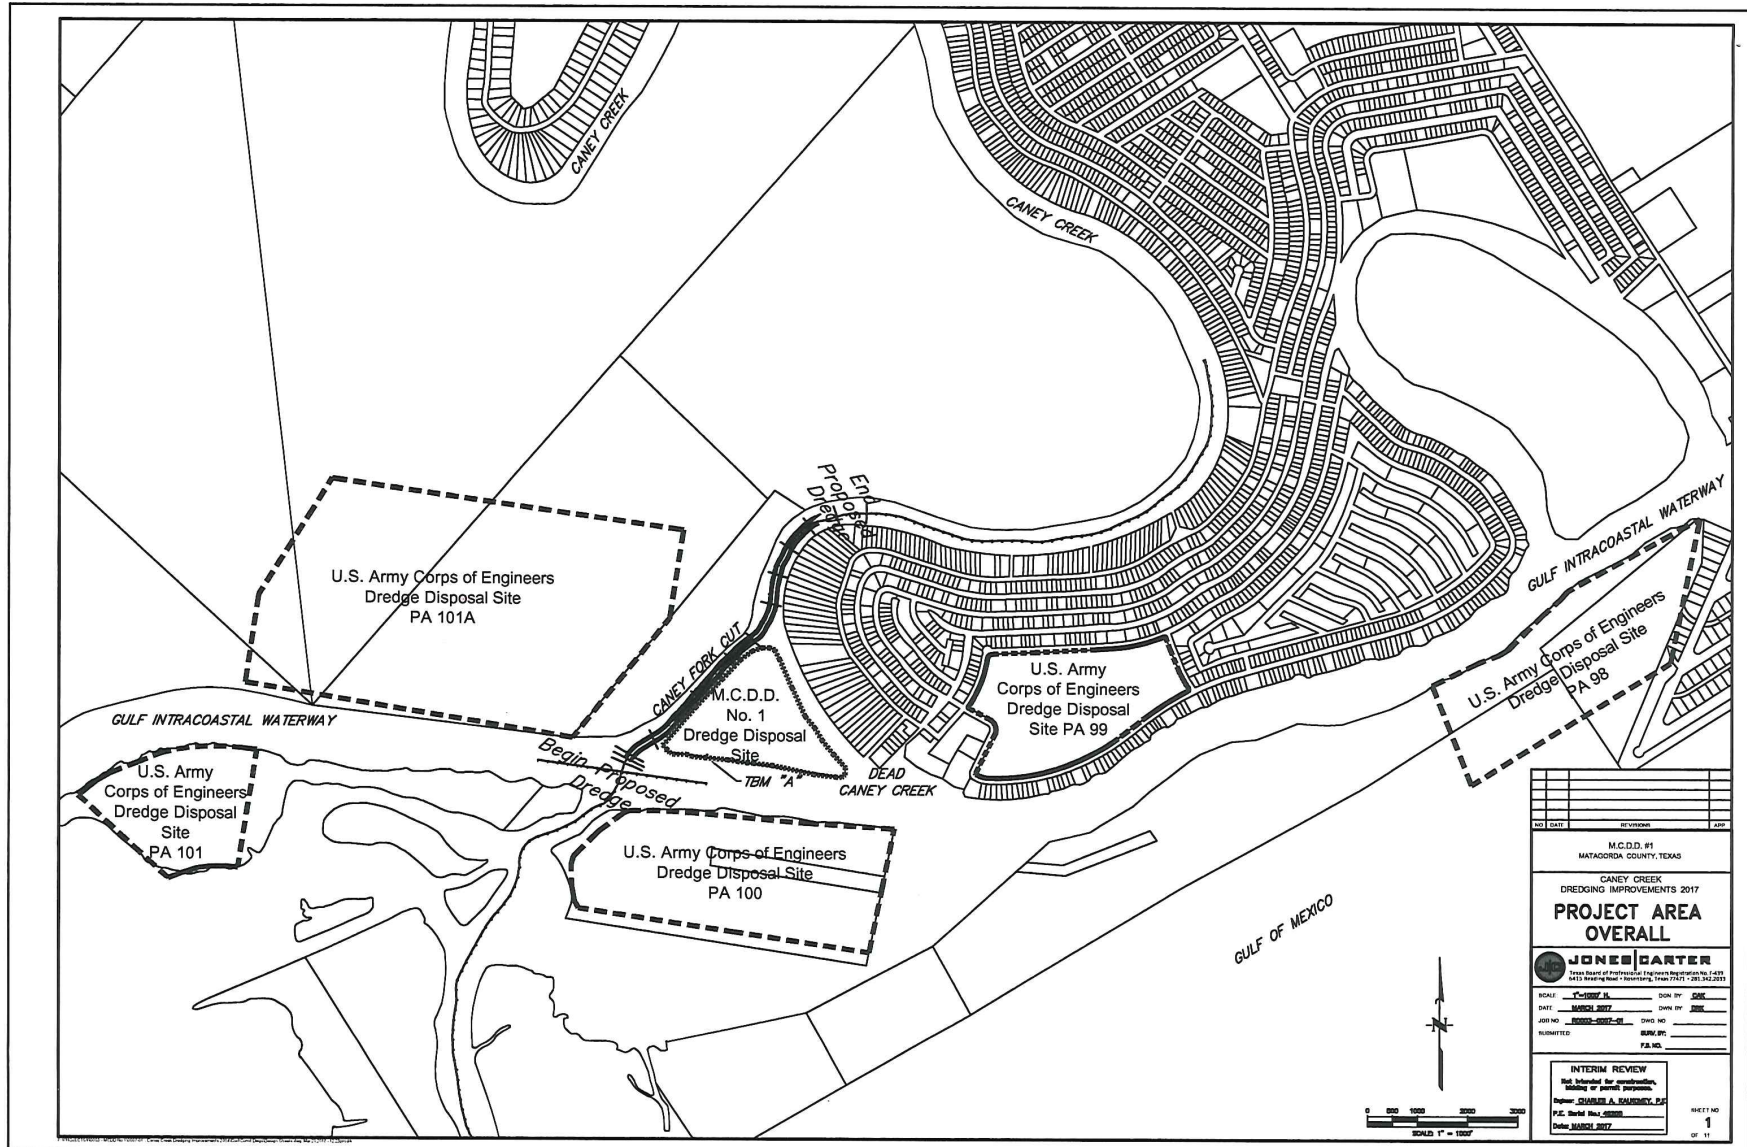


MAR 27 2017



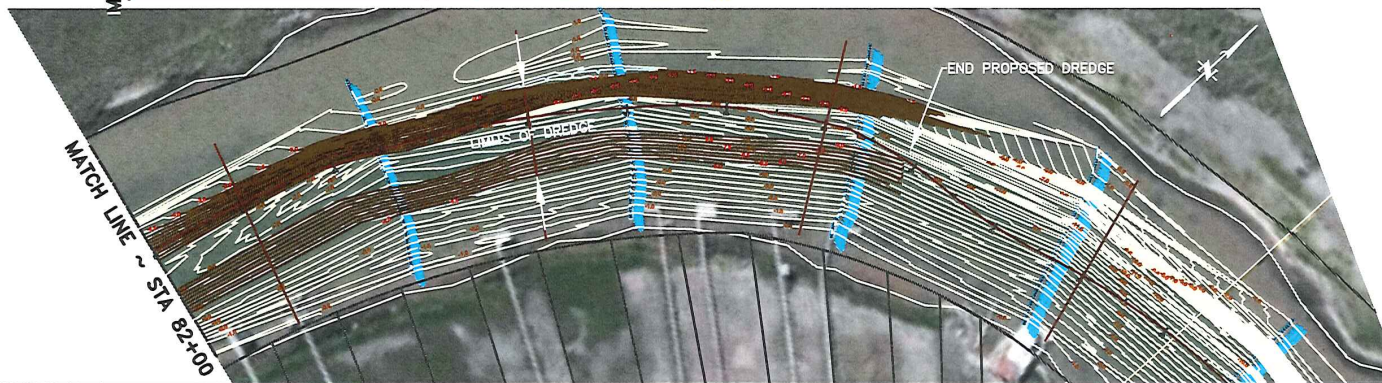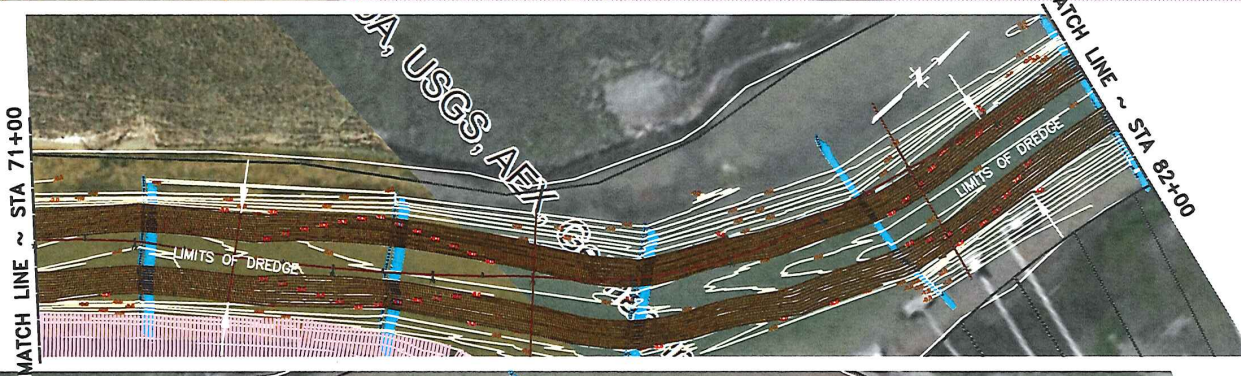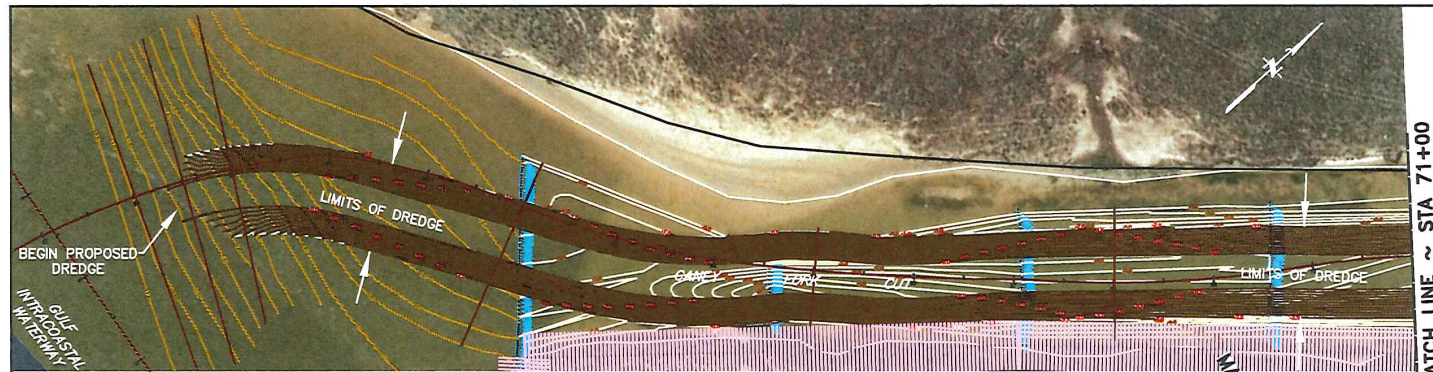


NO.	DATE	REVISION	APP.
M.C.D.D. #1 MATAGORDA COUNTY, TEXAS			
CANEY CREEK DREDGING IMPROVEMENTS 2017			
DREDGE PLAN			
Track Record of Professional Engineering Services for over 40 years 14115 Harding Street - Houston, Texas 77057 - 281.241.2011			
SCALE	1"=50' H.	DATE	3/26/17
DATE	MARCH 2017	DRAWN BY	JKM
JOB NO.	20001-0007-01	CHECKED BY	
REVISIONS		DATE	
INTERIM REVIEW Reviewed for compliance with all applicable laws and regulations Project: CANEY CREEK DREDGE PLAN P.E. David A. Kautsky, P.E. Date: MARCH 2017			
SHEET NO.			5
			OF 11

MAR 27 2017

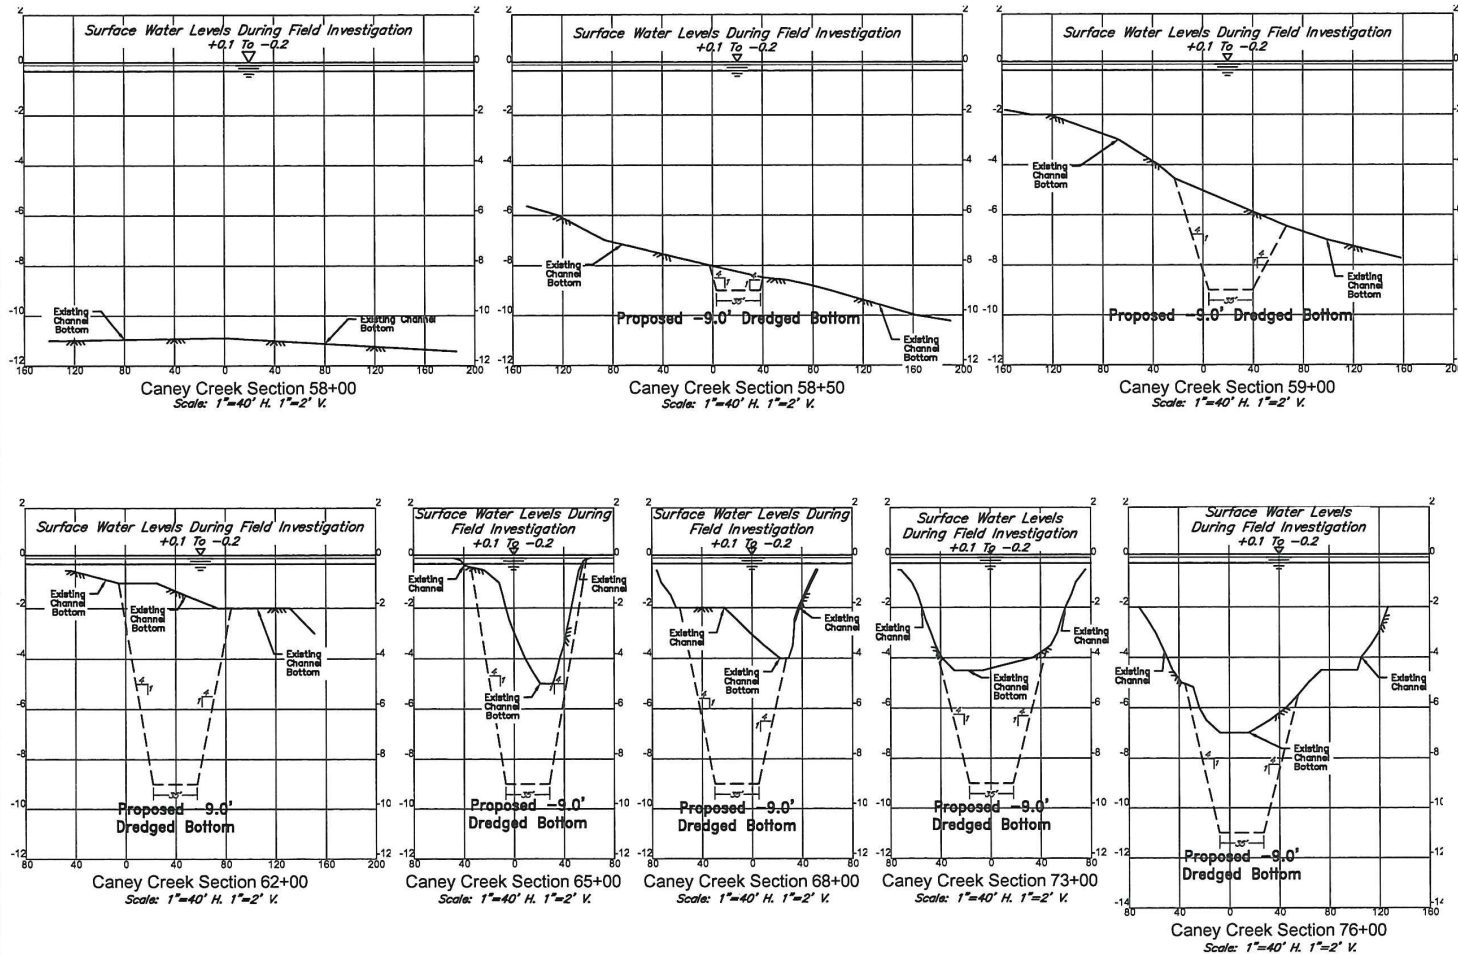



NO. DATE		REVISION	APP.
M.C.D.D. #1 MATAGORDA COUNTY, TEXAS			
CANEY CREEK DREDGING IMPROVEMENTS 2017			
PROJECT CROSS SECTIONS SHEET 1 OF 2			
JONES & CARTER Texas Board of Professional Engineering Examiners No. 4433 4413 Paving Road • Houston, Texas 77057 • 281.262.2000			
SCALE:	1"=40' H, 1"=2' V	DATE:	MARCH 2017
JOB NO.	SWG-2000-02904-M	DRAWN BY:	CHS
SUBMITTED:		CHECKED BY:	CHS
		DATE:	MARCH 2017
INTERIM REVIEW Not intended for construction, binding or permit purposes. Prepared: CHARLES A. SANDREY, P.E. P.E. State No. 20088 Date: MARCH 2017			
SHEET NO.			4
			OF 11

MAR 27 2017

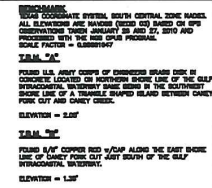

NO.	DATE	REVISION/NO.	APP.
M.C.D.D. #1 MATACORDA COUNTY, TEXAS CANEY CREEK DREDGING IMPROVEMENTS 2017 PROJECT CROSS SECTIONS SHEET 2 OF 2			
 JAMES B. CARTER Texas Board of Professional Engineering Registration No. 4293 Exp. 08/15/2022 Tomball, Texas 77475 Tel. 281.268.2228			
SCALE: <u>1" = 40' H. P. & V. V.</u>		DRAWN BY: <u>JDSE</u>	
DATE: <u>MARCH 2017</u>		CHECKED BY: <u>JDSE</u>	
JOB NO: <u>2016-0002-01</u>		SYNO. NO: _____	
SUBMITTED: _____		APPROV. BY: _____	
		P.E. NO. _____	
INTERVIEW REVIEW Not scheduled for amendment, addition or project progress. Prepared: CHARLES A. SEABURN, P.E. P.E. State of Texas, #00888 Date: MARCH 2017			
			SHEET NO. 5 OF 5

 MAR 27 2017

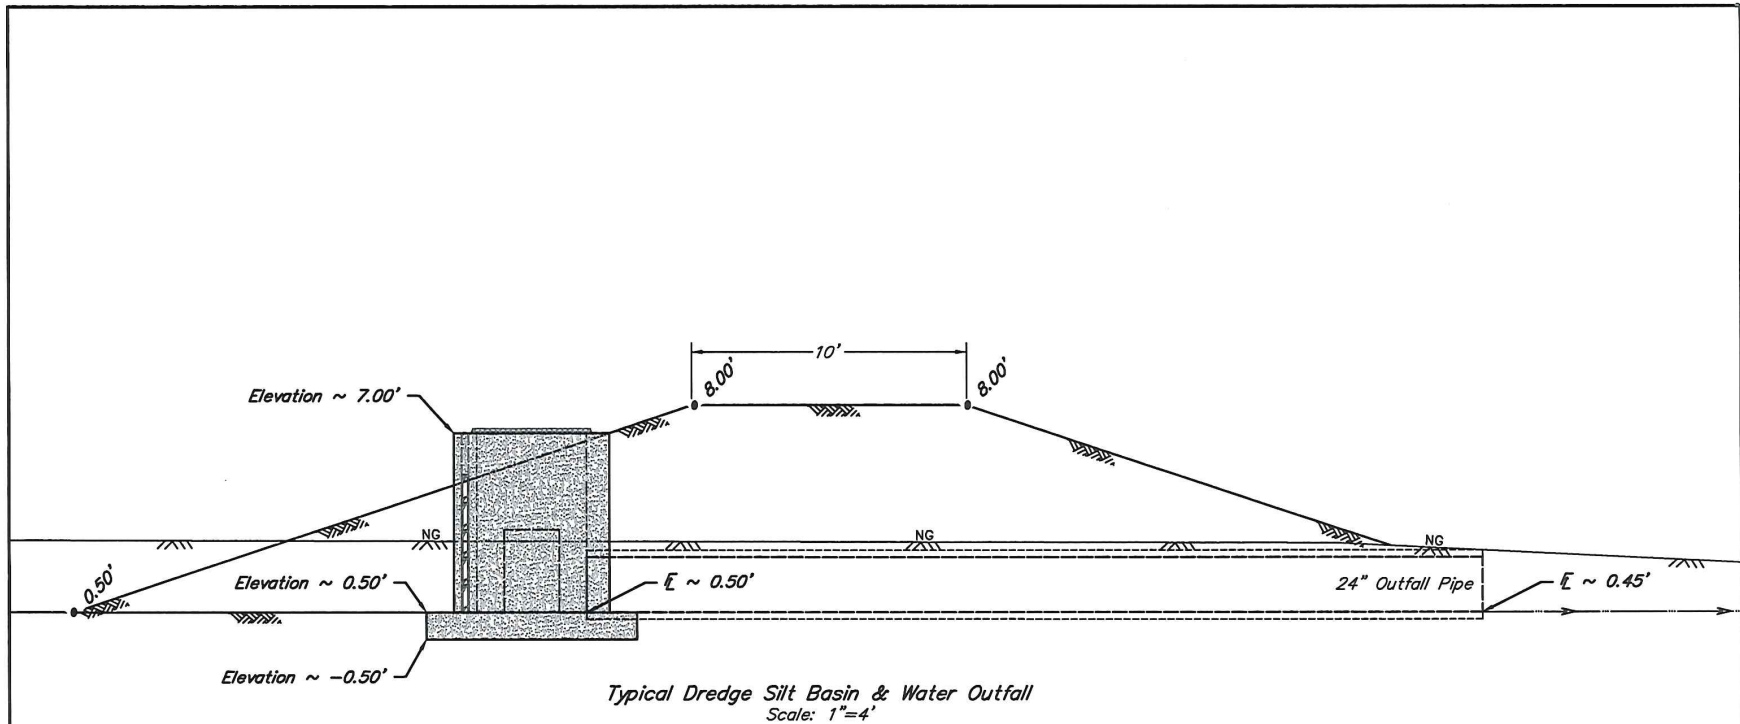



M.C.D.D. # 1
CANEY CREEK DREDGING IMPROVEMENTS 2017
PROPOSED SILT BASIN
TYPICAL OUTFALL EXHIBIT
MARCH 2017
J/C Job No. R0003-0007-01


MAR 27 2017

EXHIBIT SHEET 6 OF 11



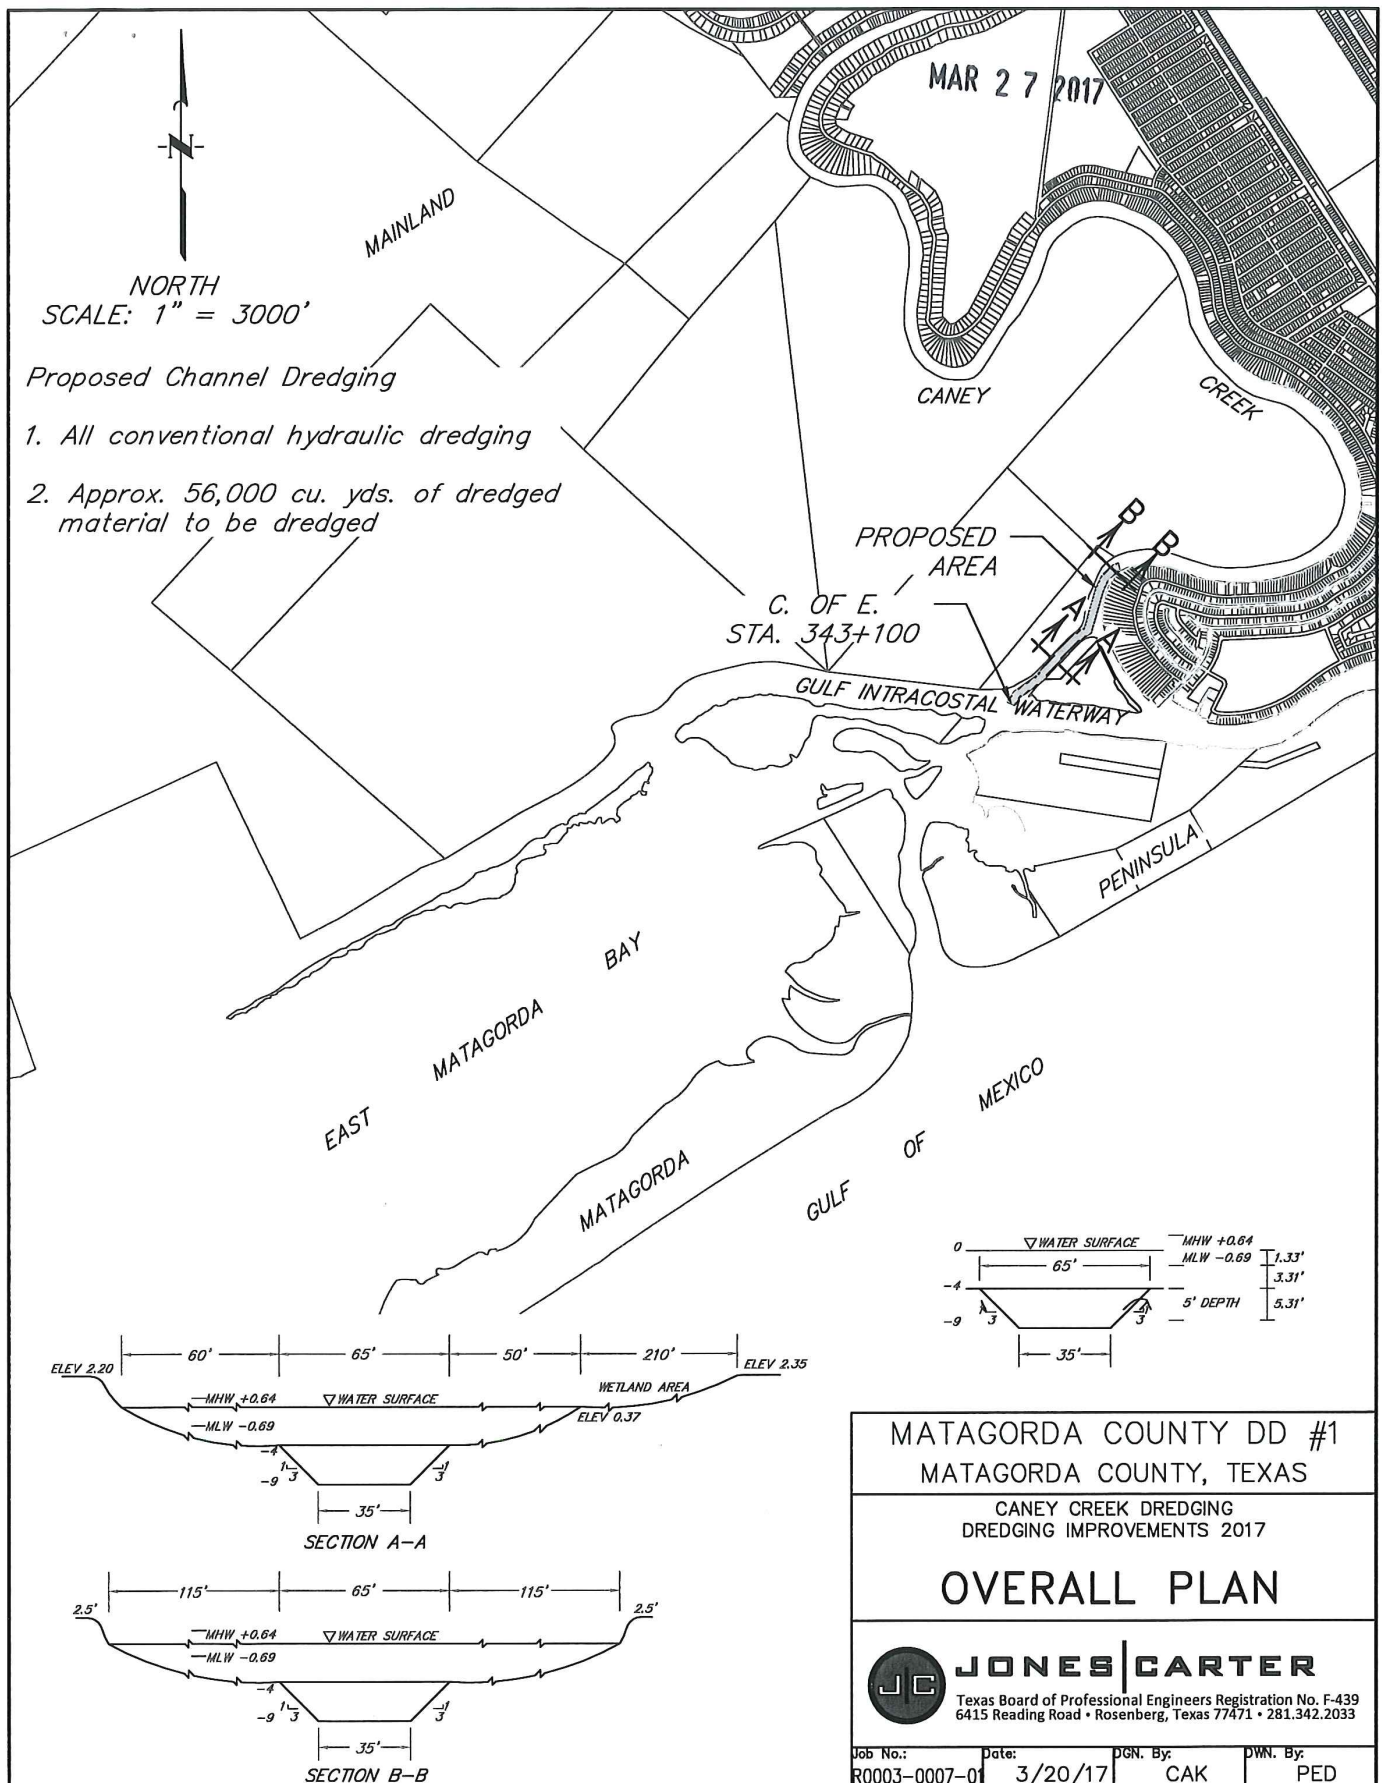

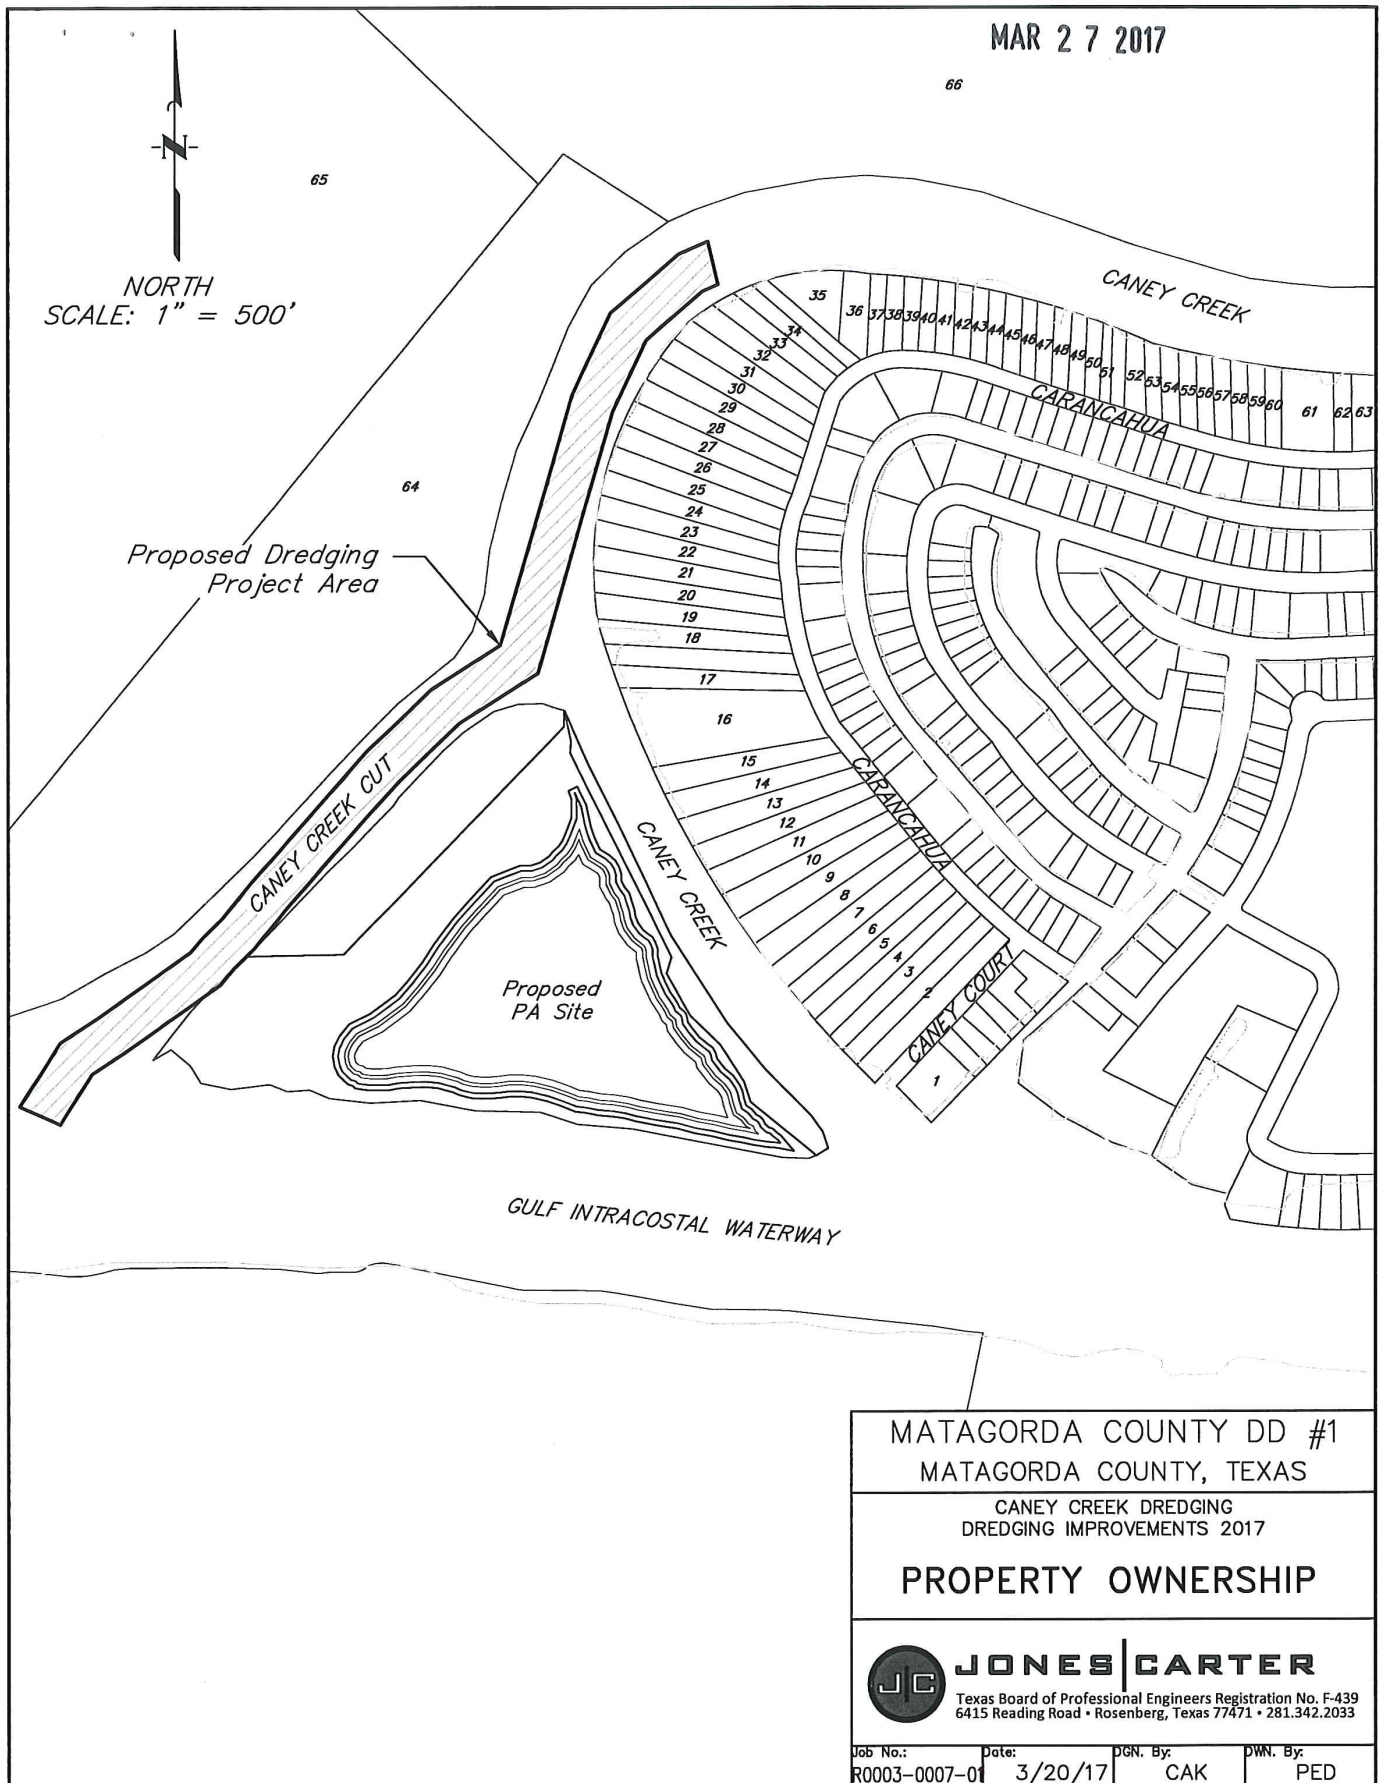

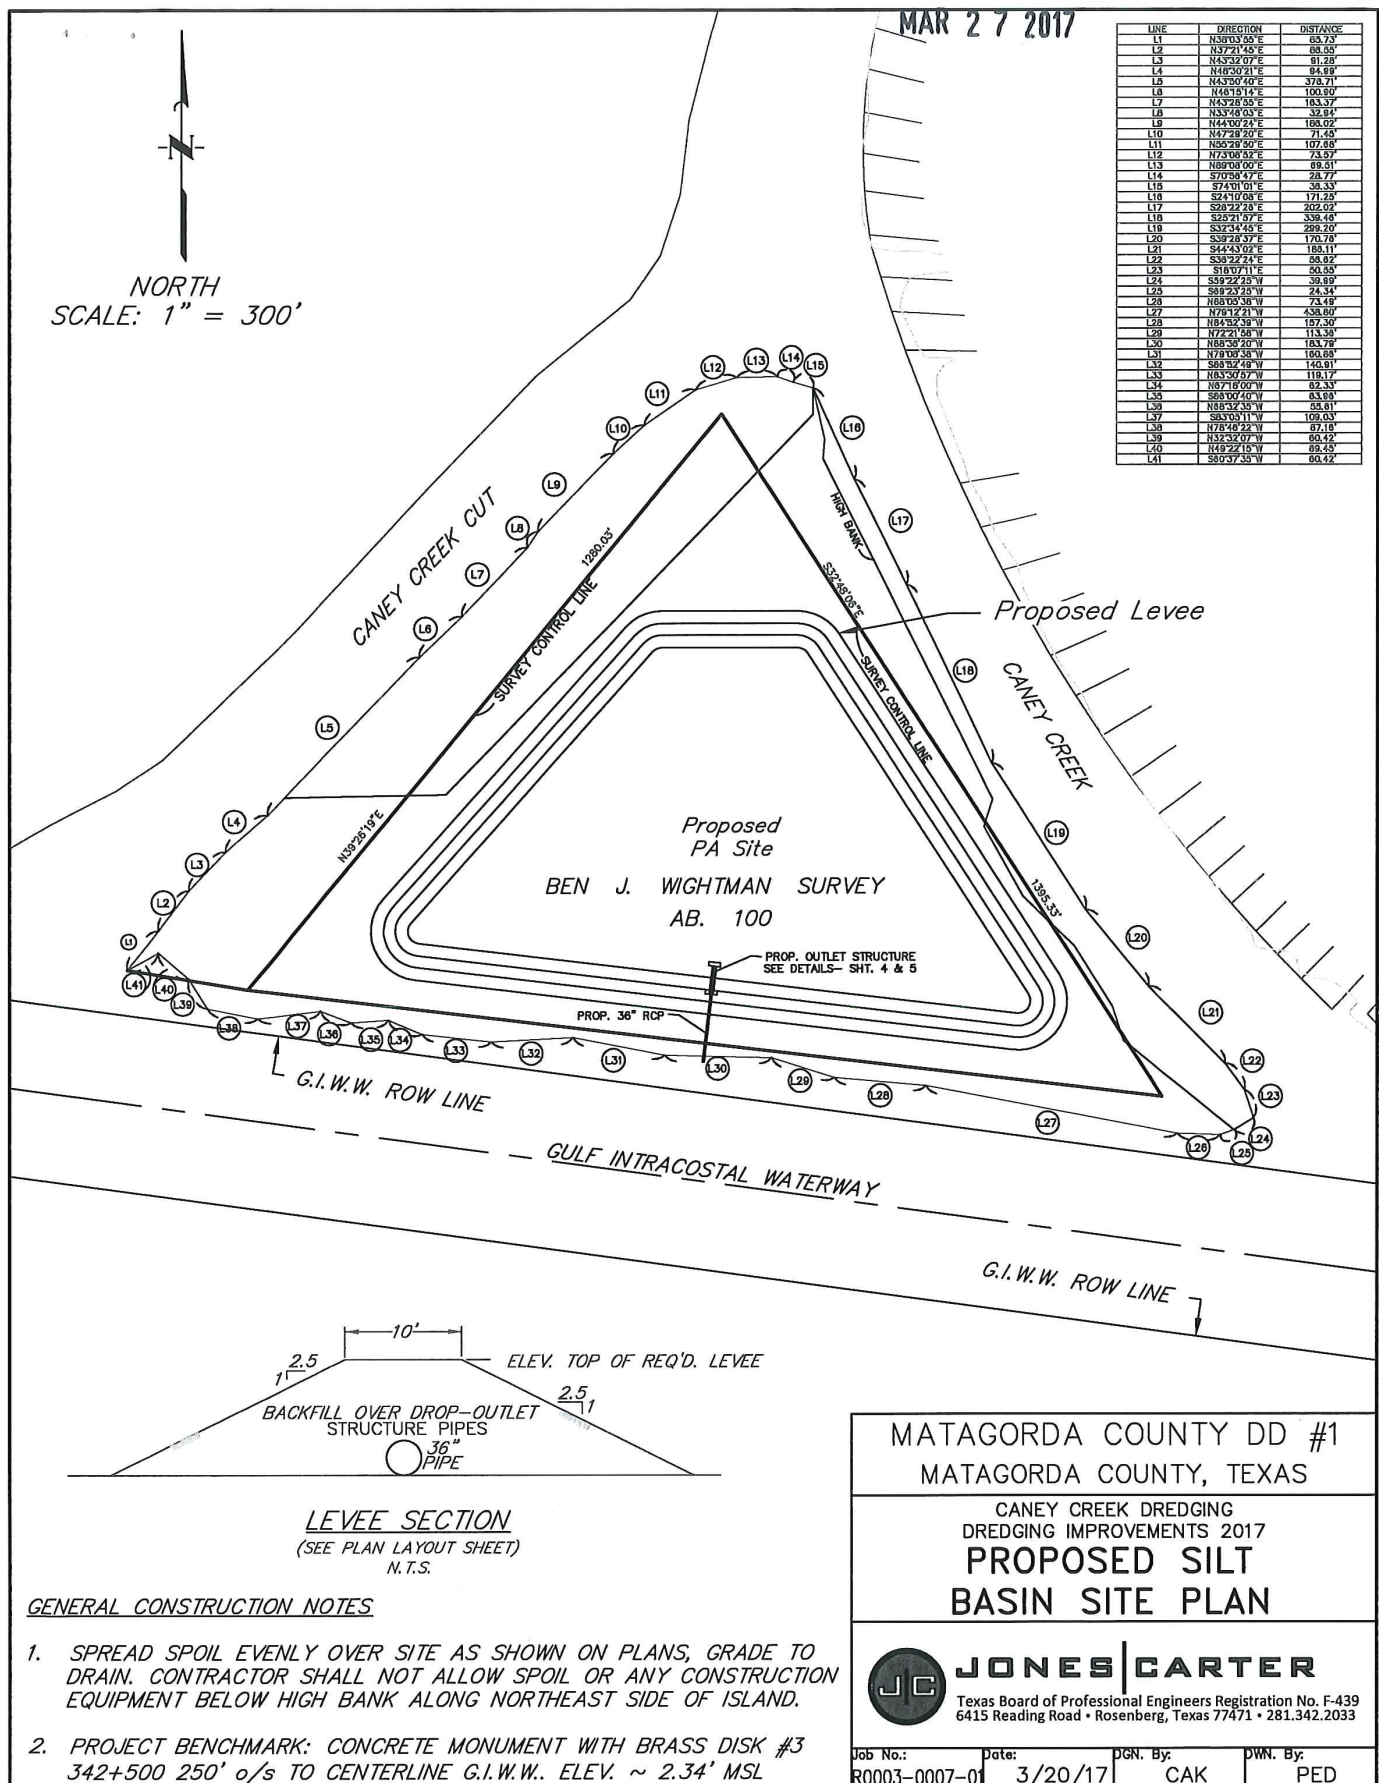

MATAGORDA COUNTY DD #1
MATAGORDA COUNTY, TEXAS

CANEY CREEK DREDGING
DREDGING IMPROVEMENTS 2017
**PROPOSED SILT
BASIN SITE PLAN**



JONES | CARTER

Texas Board of Professional Engineers Registration No. F-439
6415 Reading Road • Rosenberg, Texas 77471 • 281.342.2033

Job No.: R0003-0007-01 Date: 3/20/17 DGN. By: CAK DWN. By: PED

EXHIBIT SHEET 10 OF 11

MAR 27 2017

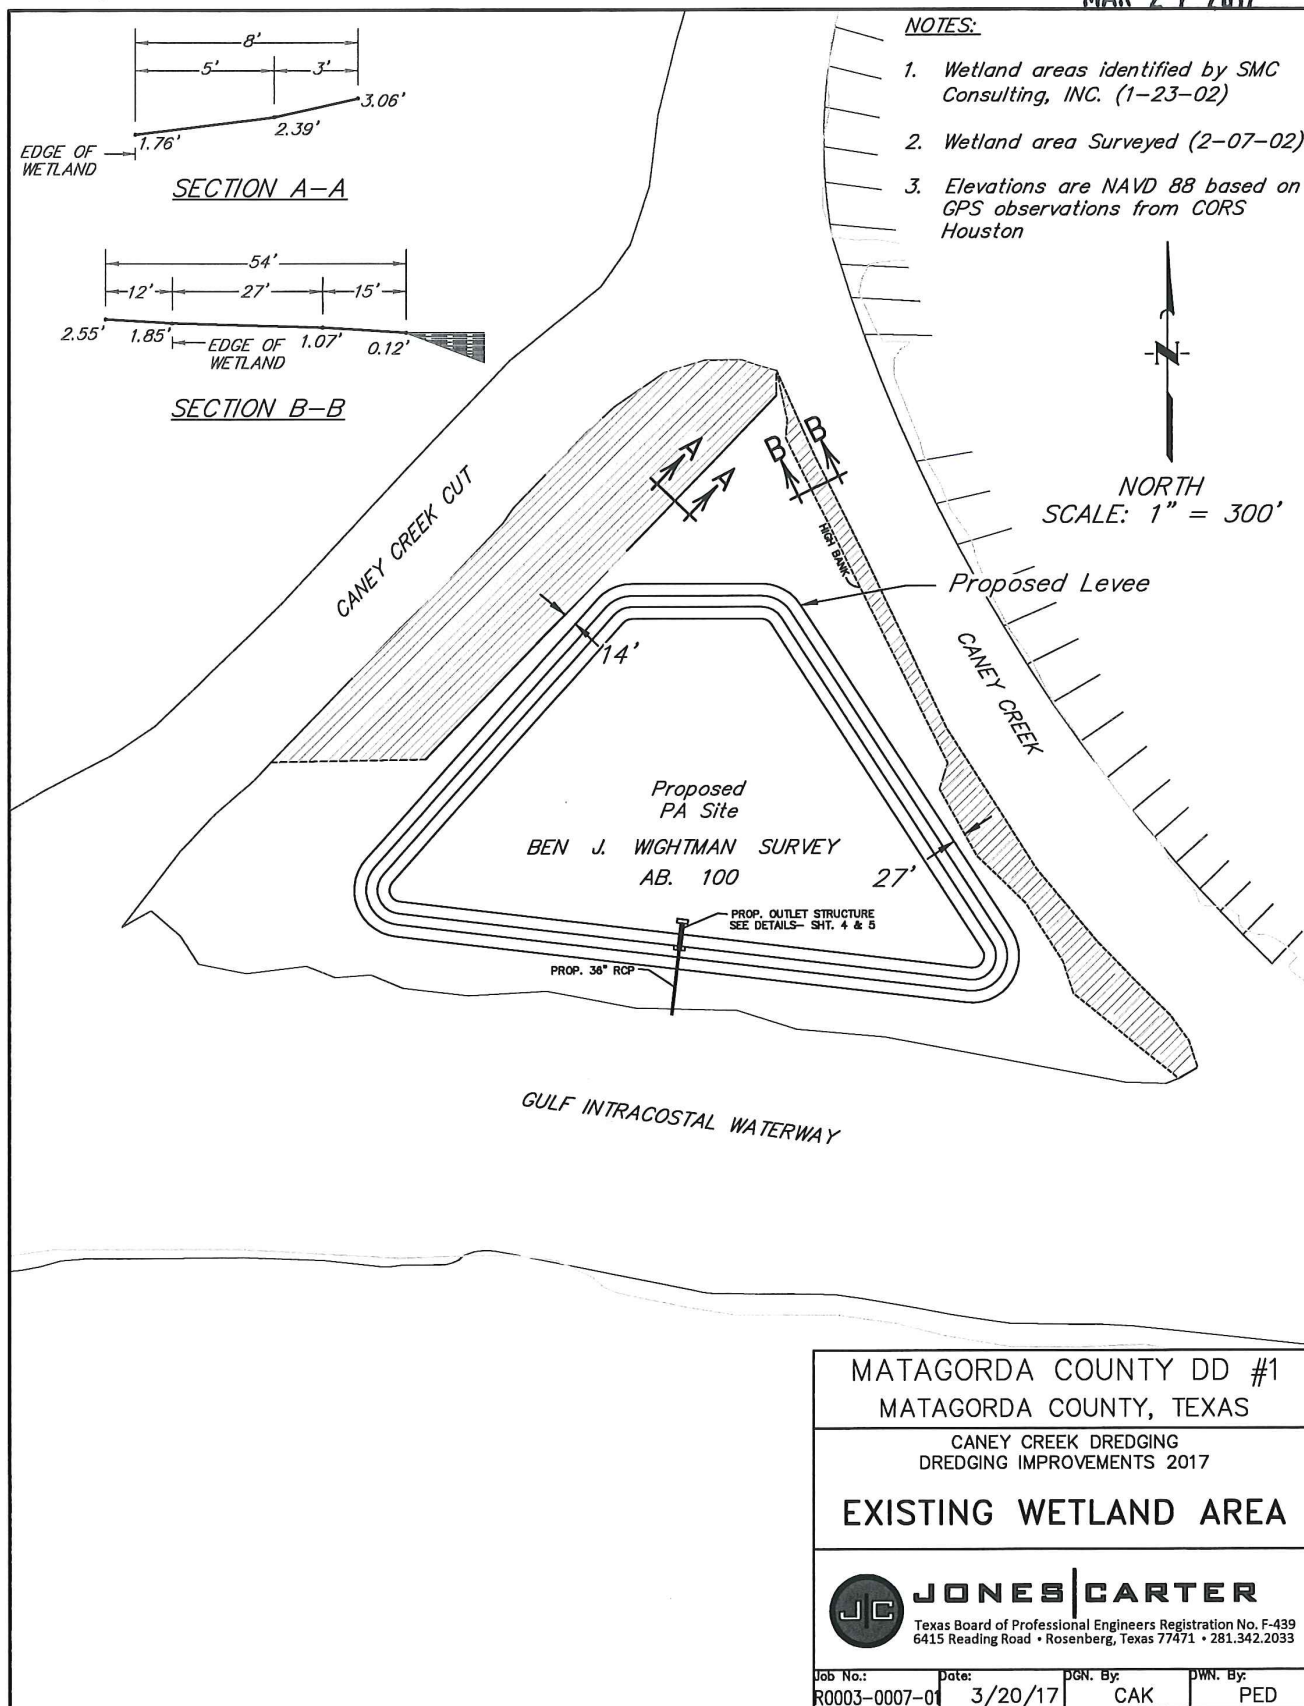


EXHIBIT SHEET 11 OF 11